




M98
25807.003

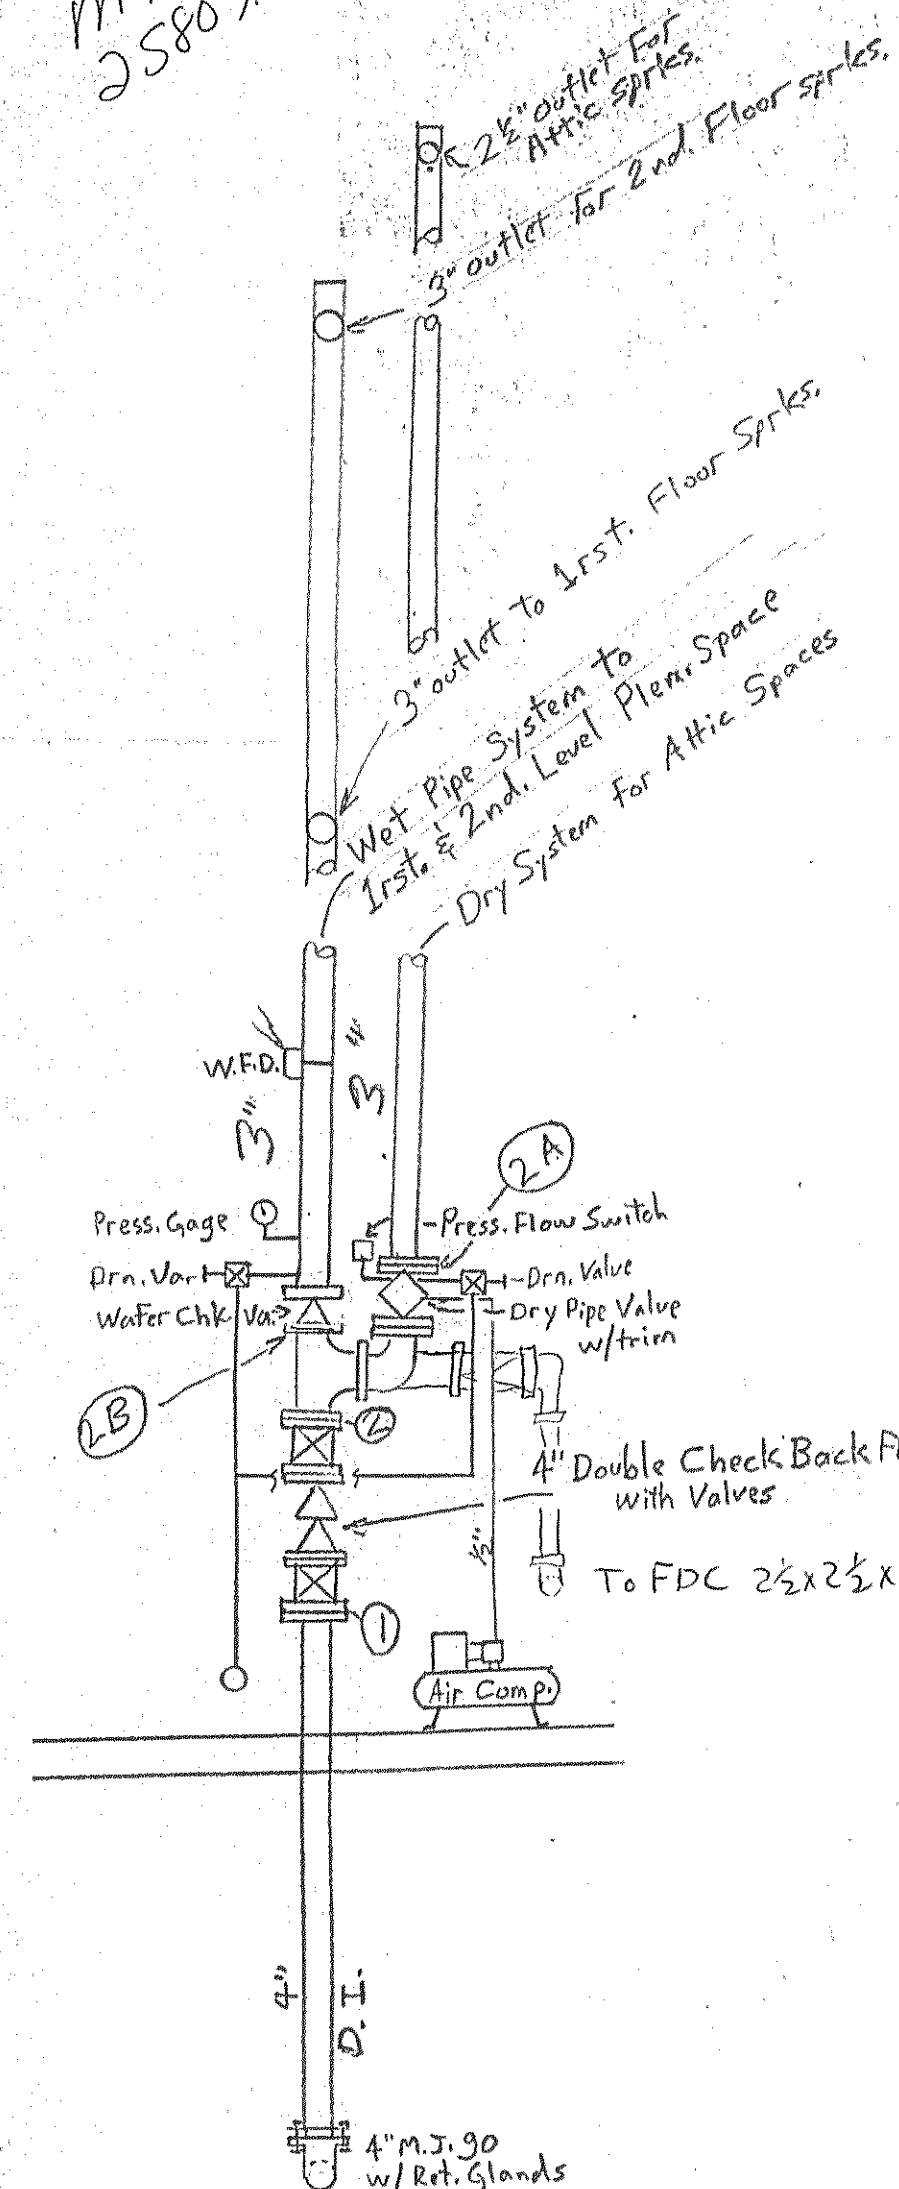


RISER DETAIL
N.T.S.

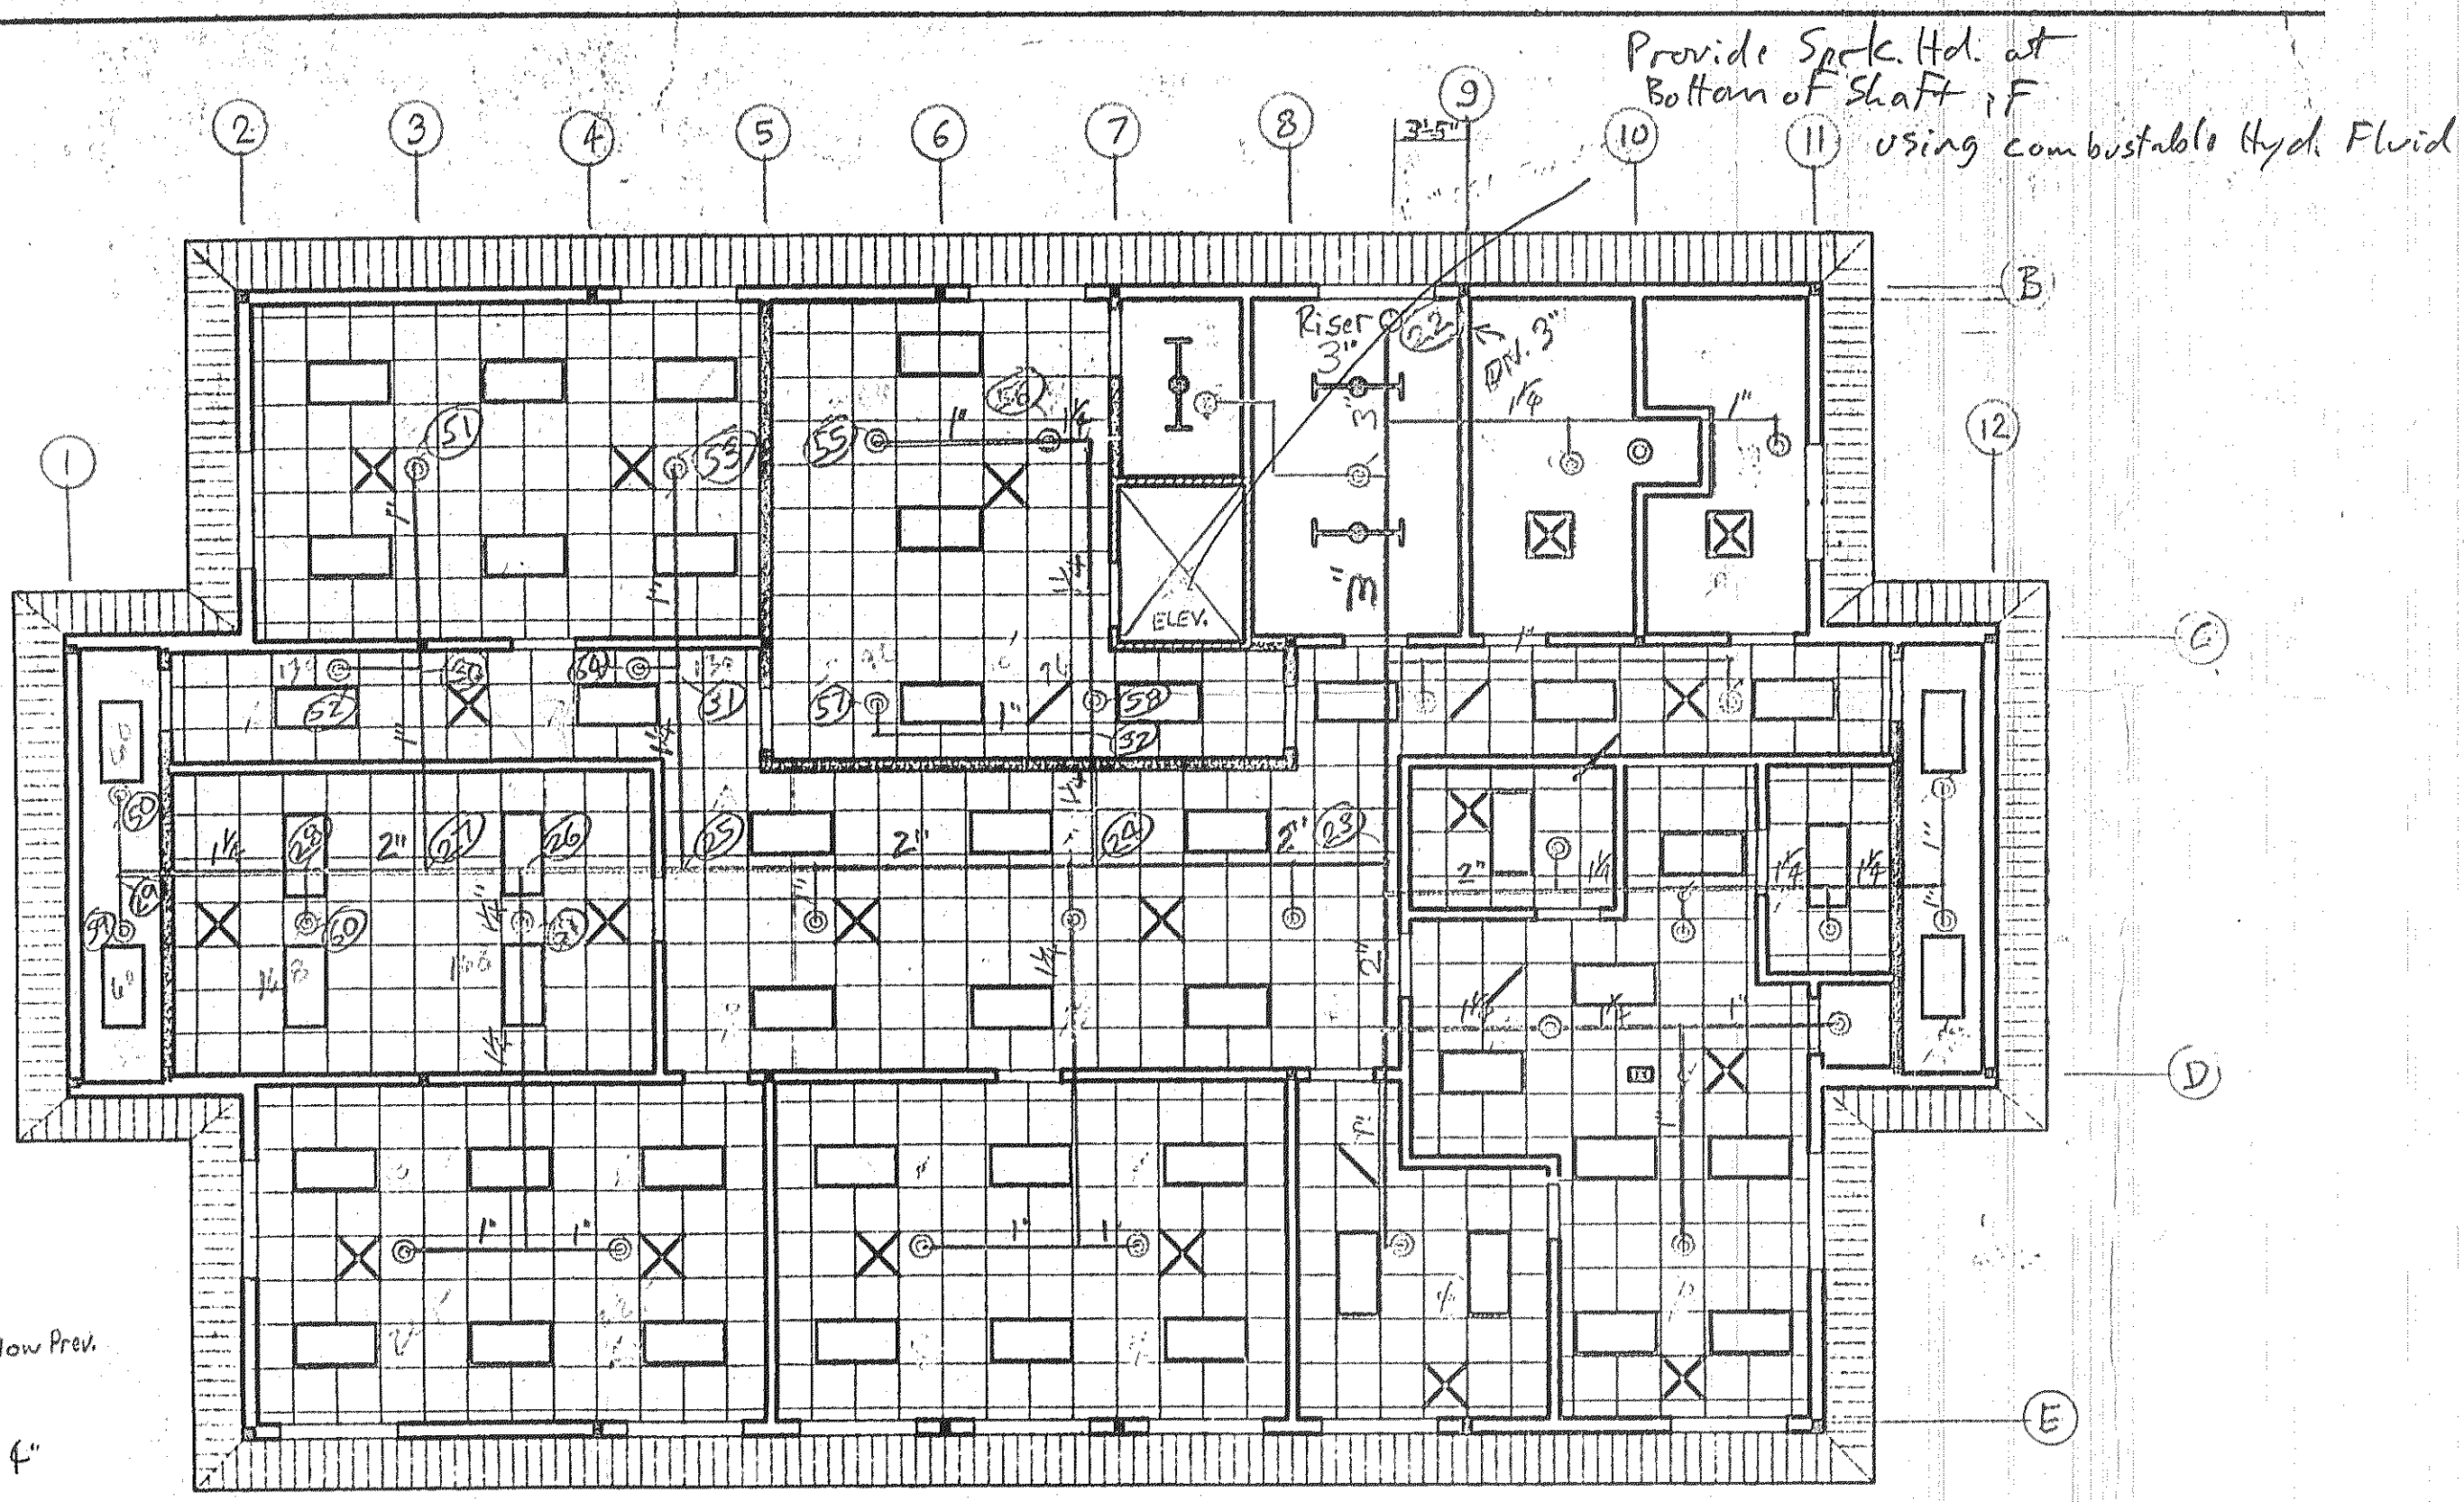

SECOND FLOOR
REFLECTED CEILING PLAN
SCALE: 1/8" = 1'-0"

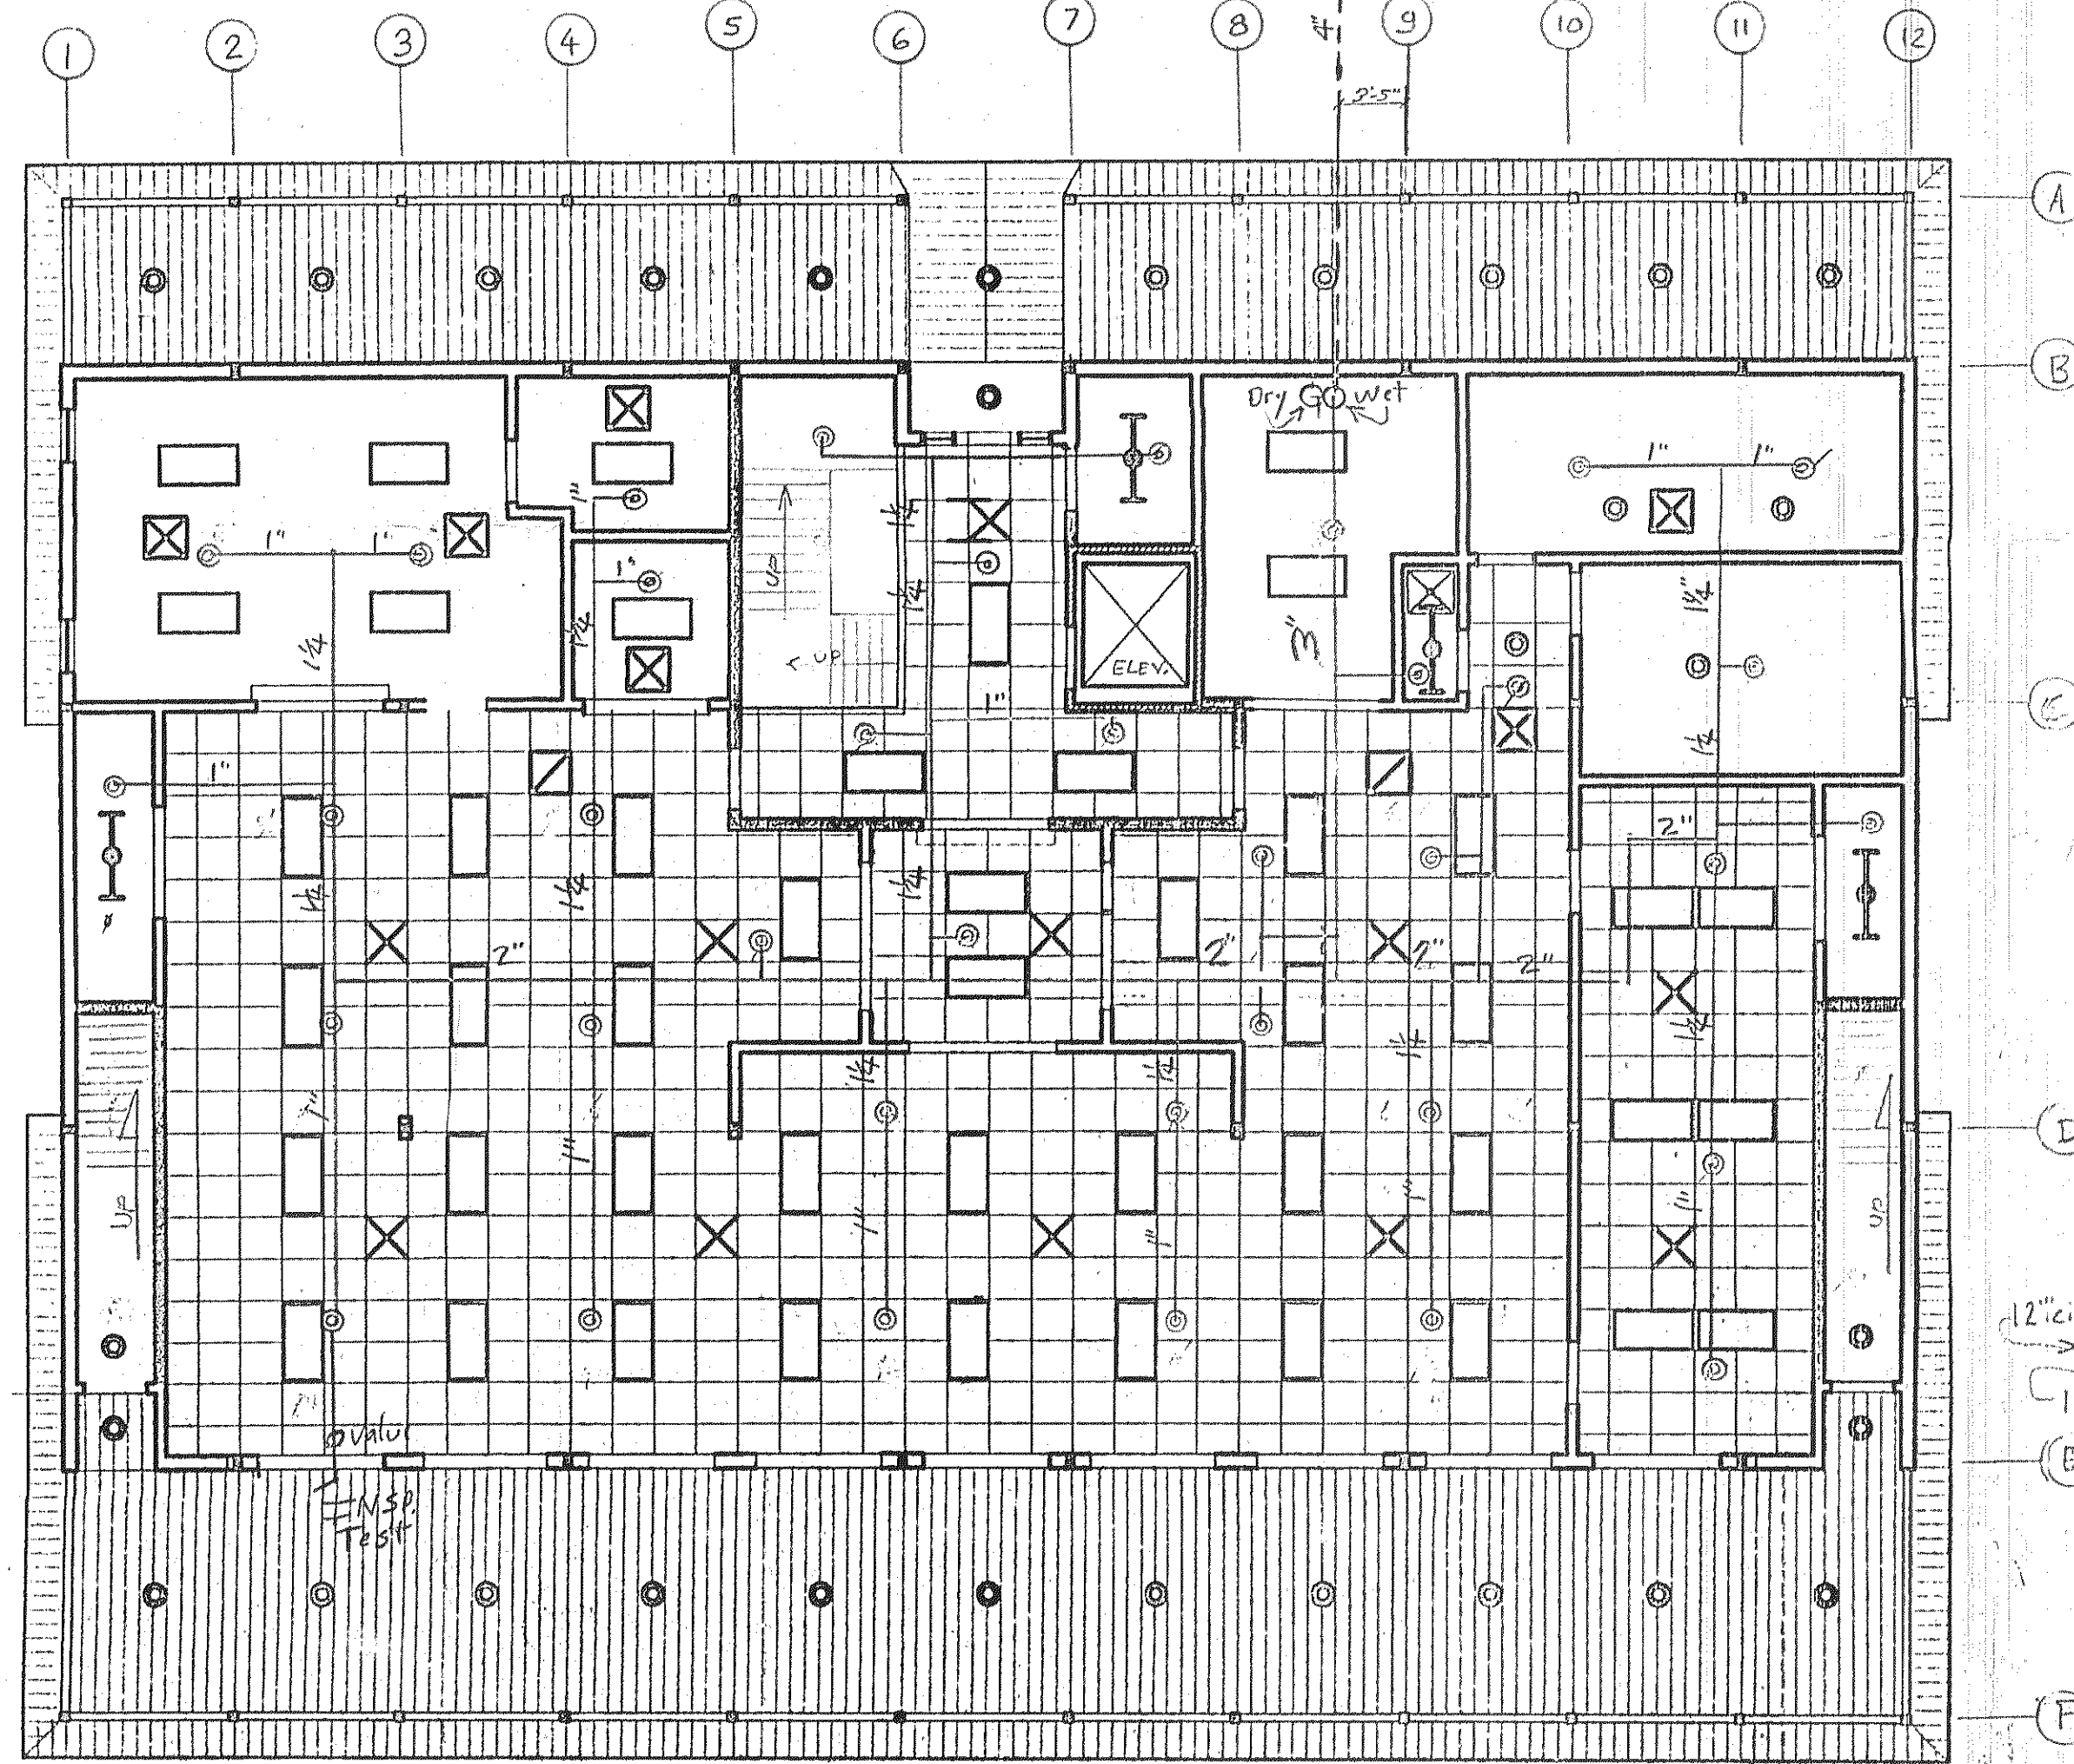


FIRST FLOOR
REFLECTED CEILING PLAN
SCALE: 1/8" = 1'-0"

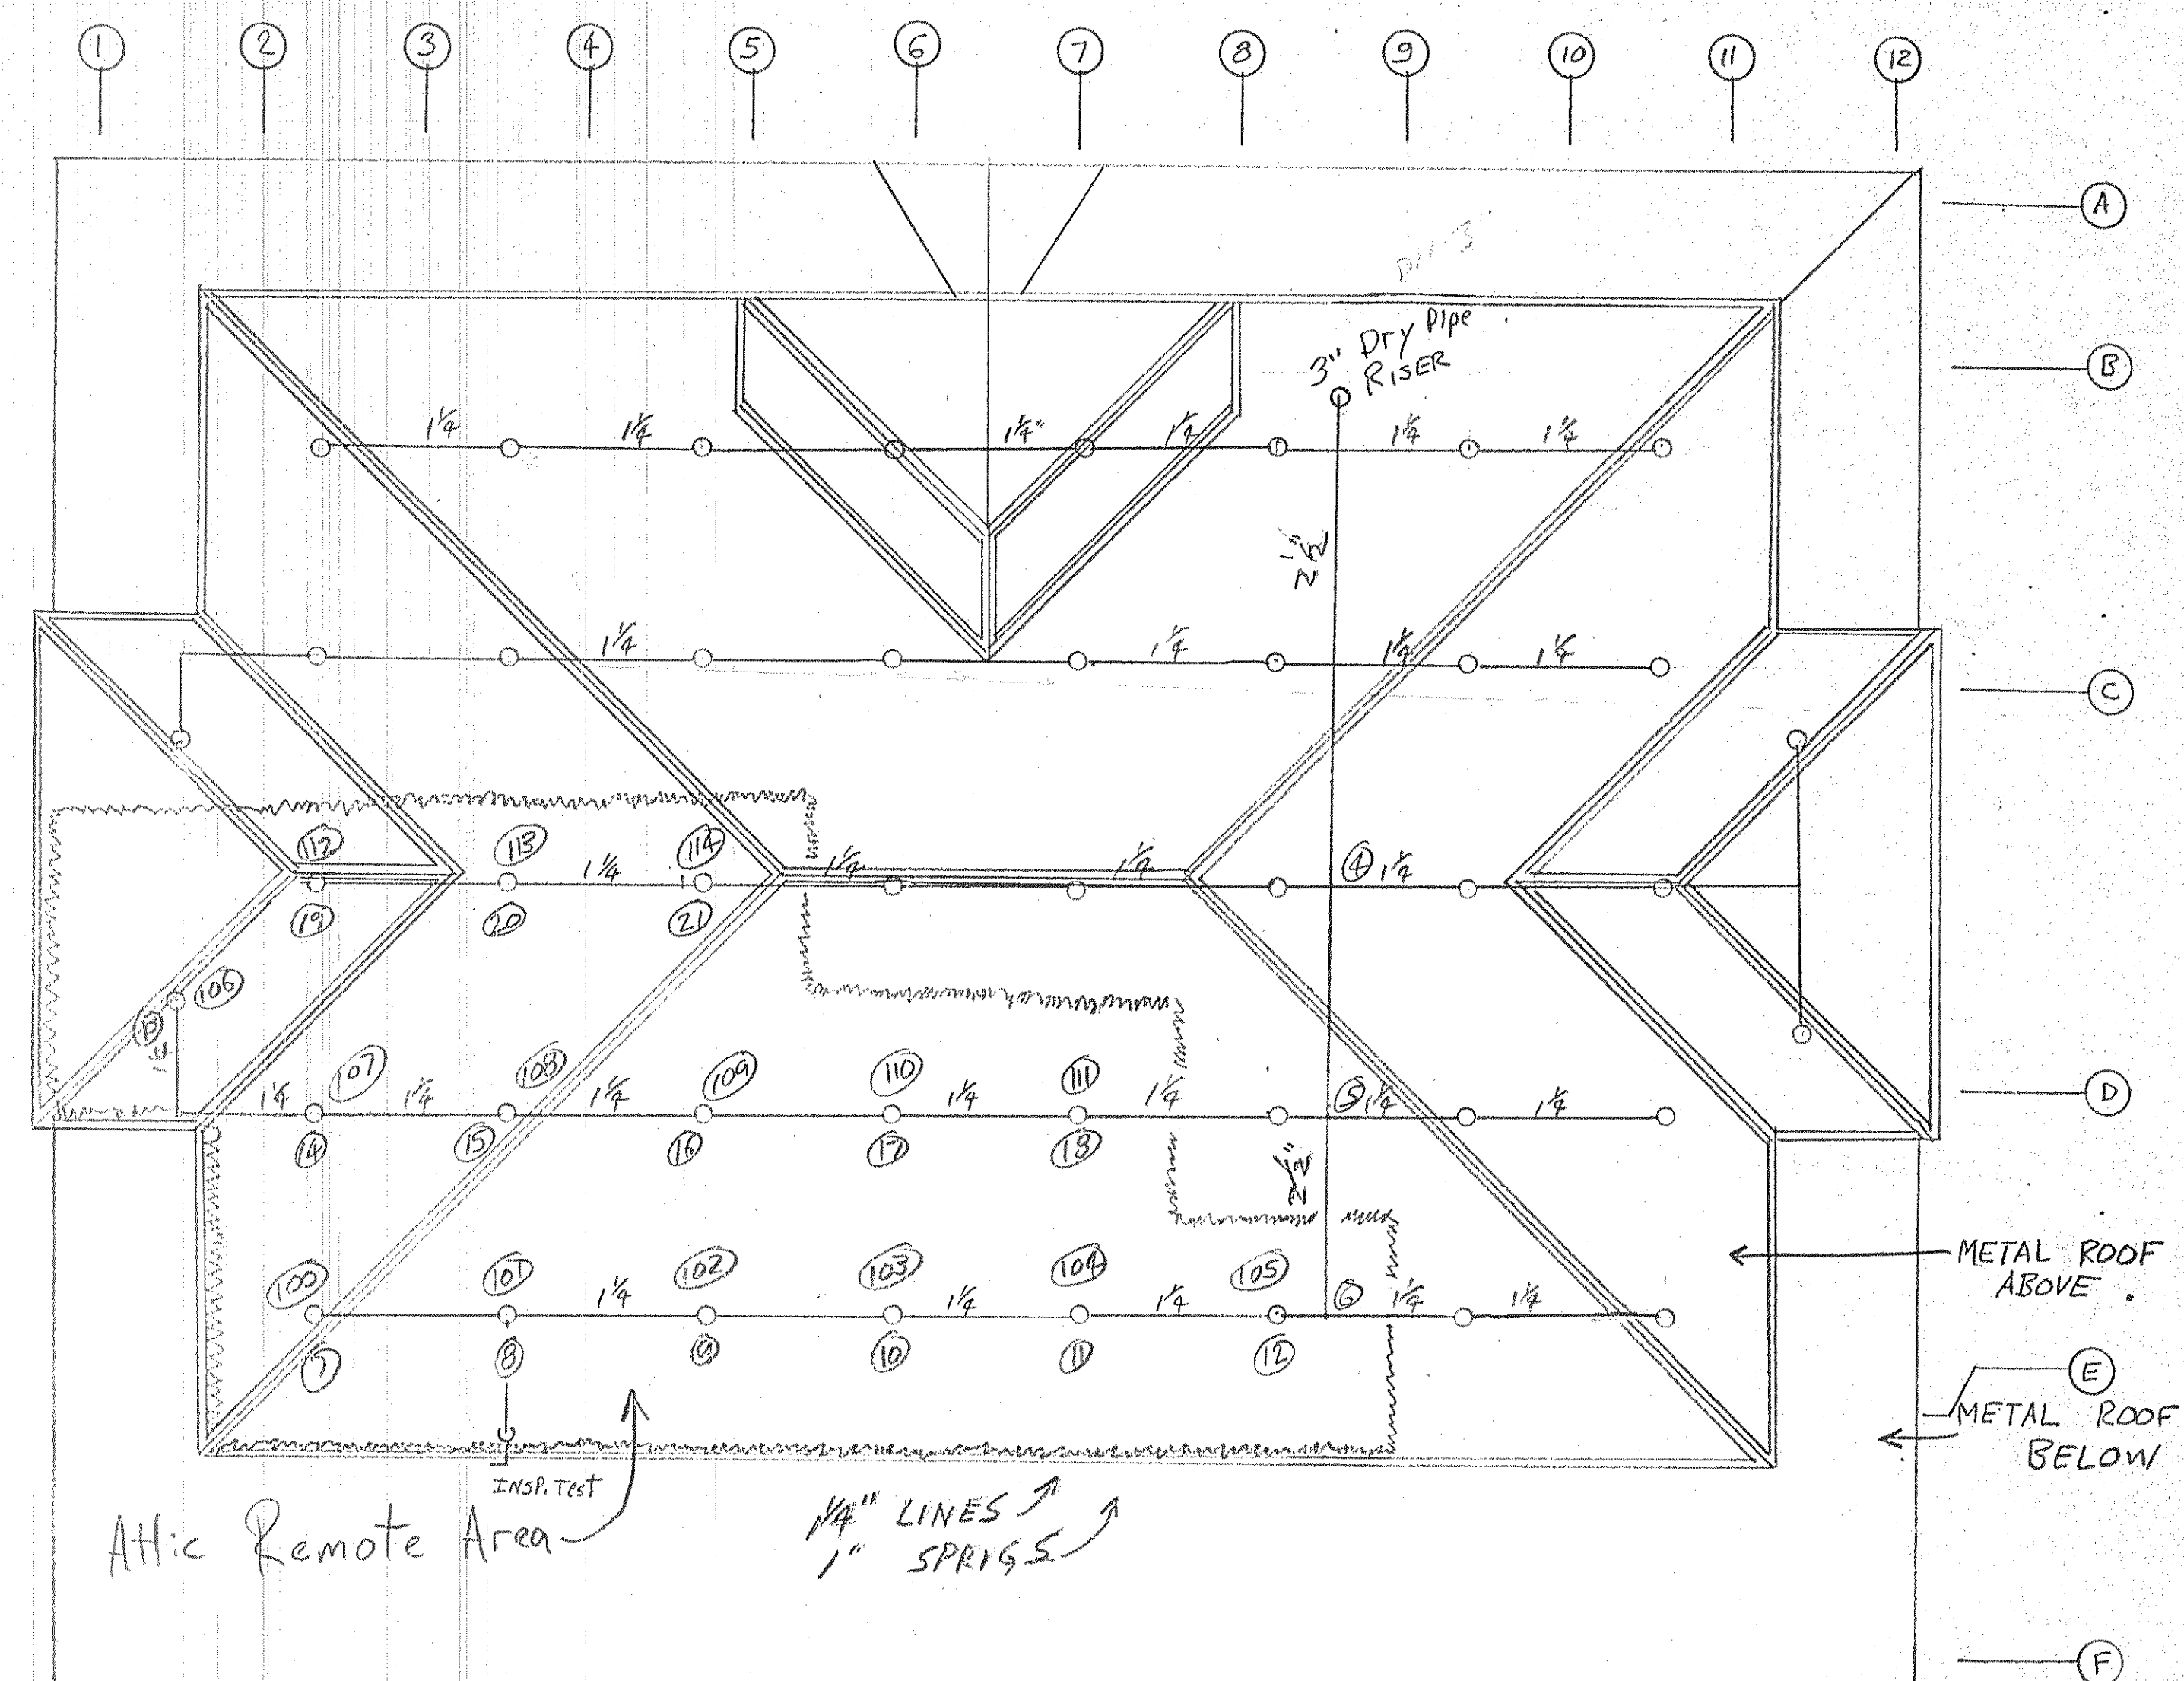

ROOF PLAN

Scale - 1/8" = 1'-0"

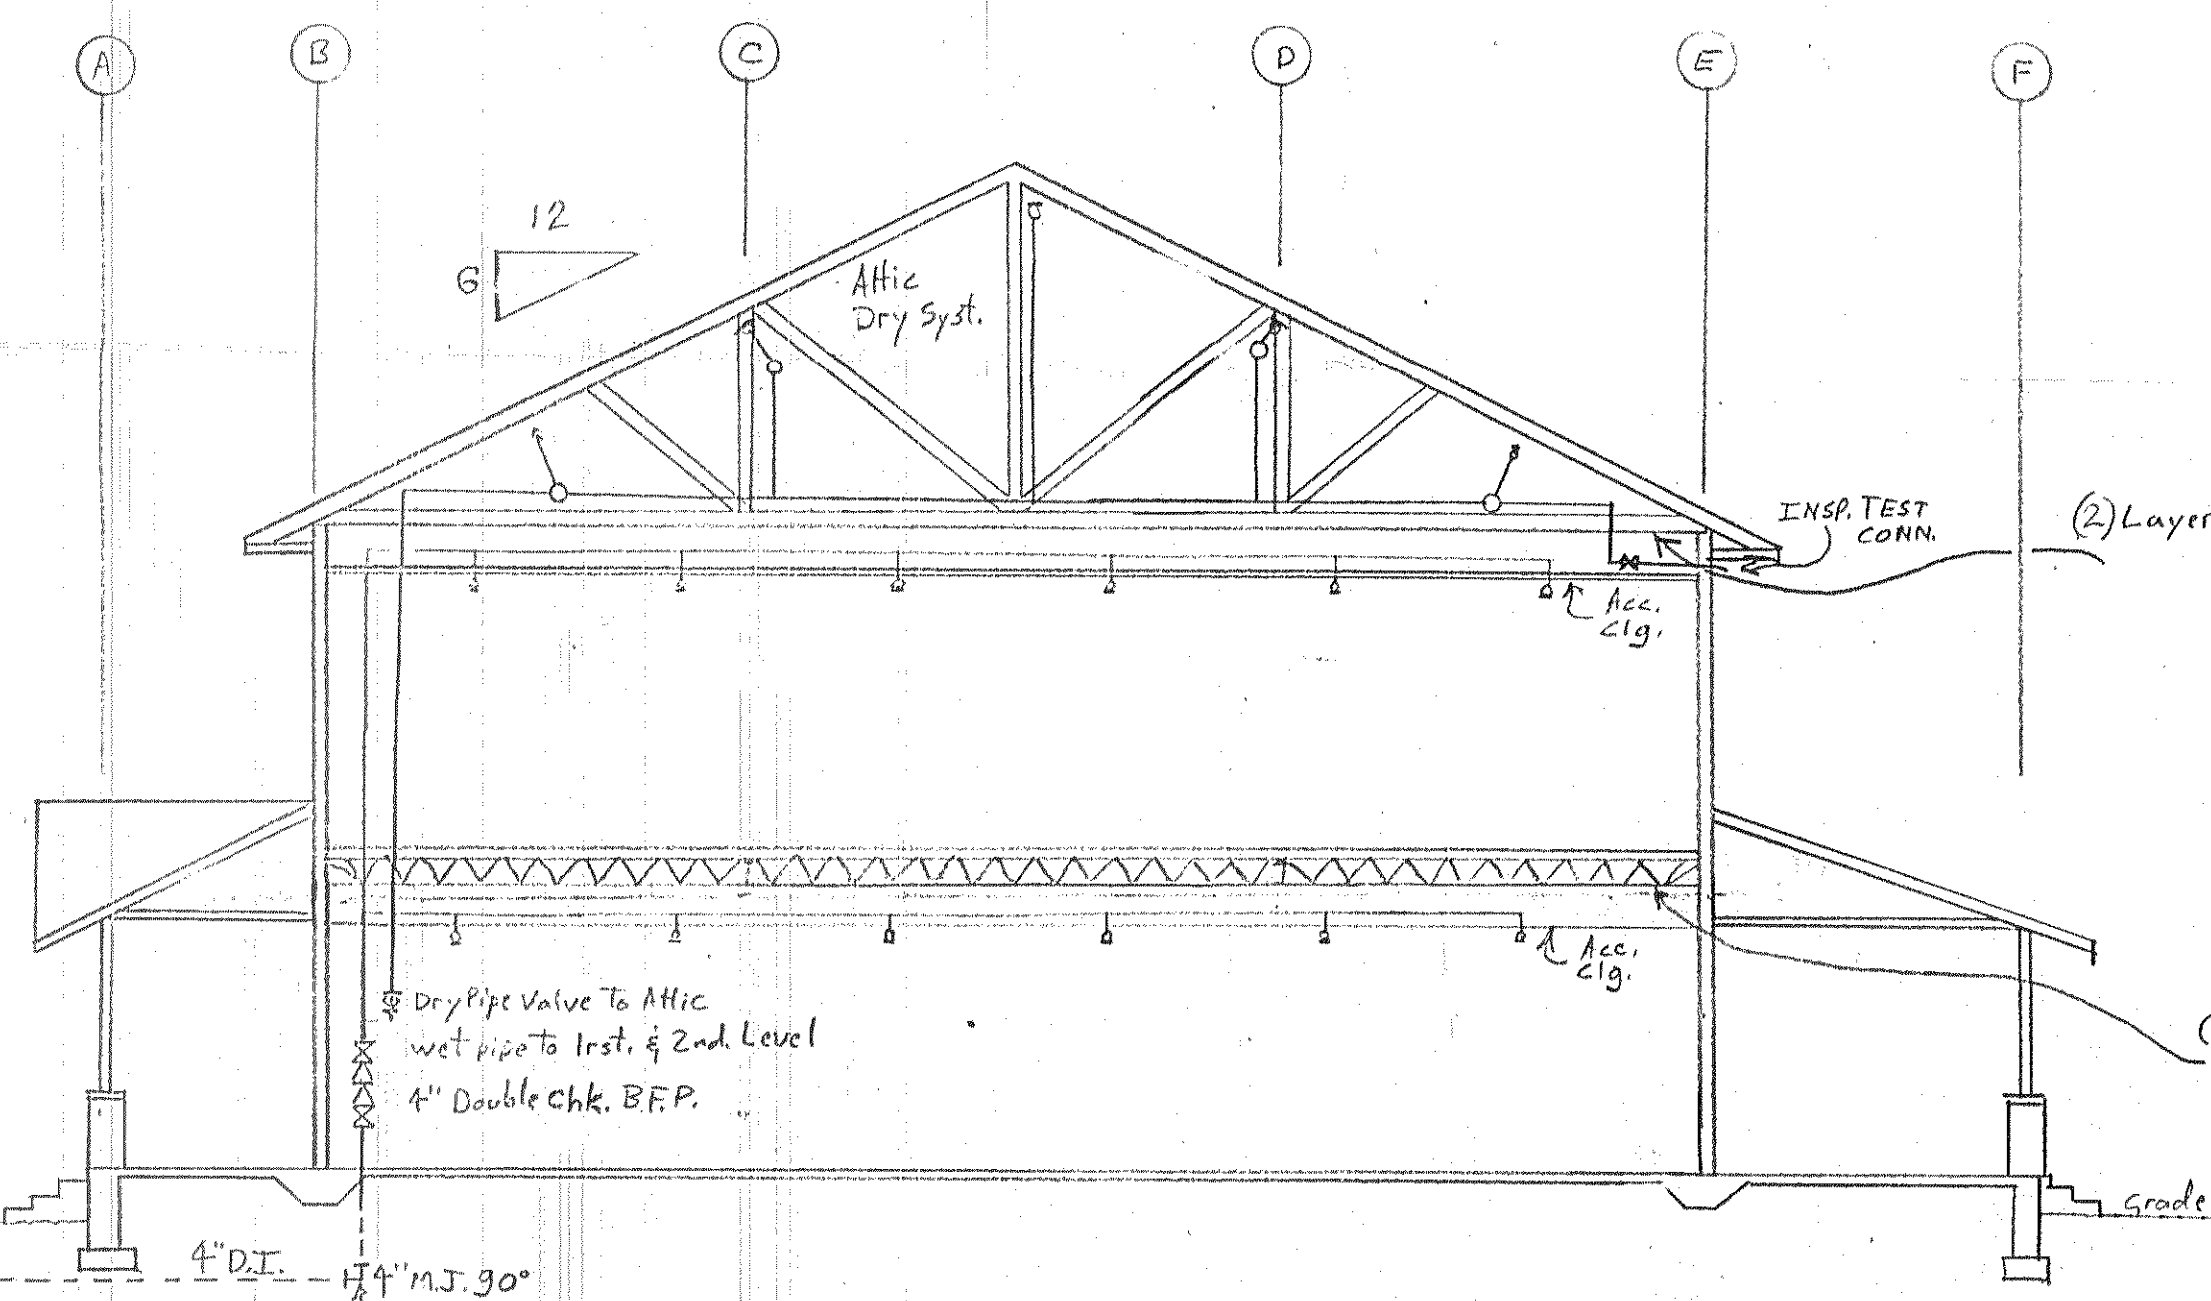

Notes:


1. Attic System is Dry Valve w/ Steel Pipe.
2. 1st. & 2nd. Level Sprks. are wet system with CPVC Pipe & Fittings 1"-2" only
3. System installed per Light Hazard, NFPA-13 requirements
4. Electric Flow Switches with Bell provided.
5. O - indicates Hydraulic node point - See Cals.

RECEIVED DEC 16 1998
JACKSONVILLE FIRE PREVENTION DIVISION
NO EXCEPTIONS
EXCEPTIONS AS NOTED
SHEET #


FIRE SPRINKLER SERV. of N.E. FL.
Address: P.O. Box 97861 Jax., FL 32236 - 904-388-2012
JOB: THE BRIDGE of N.E. FL.
8th. St. Jax., FL.

Date: 12-9-98 Scale: 1/8" = 1'-0" Draw: 1 of 1


M98
25807.003

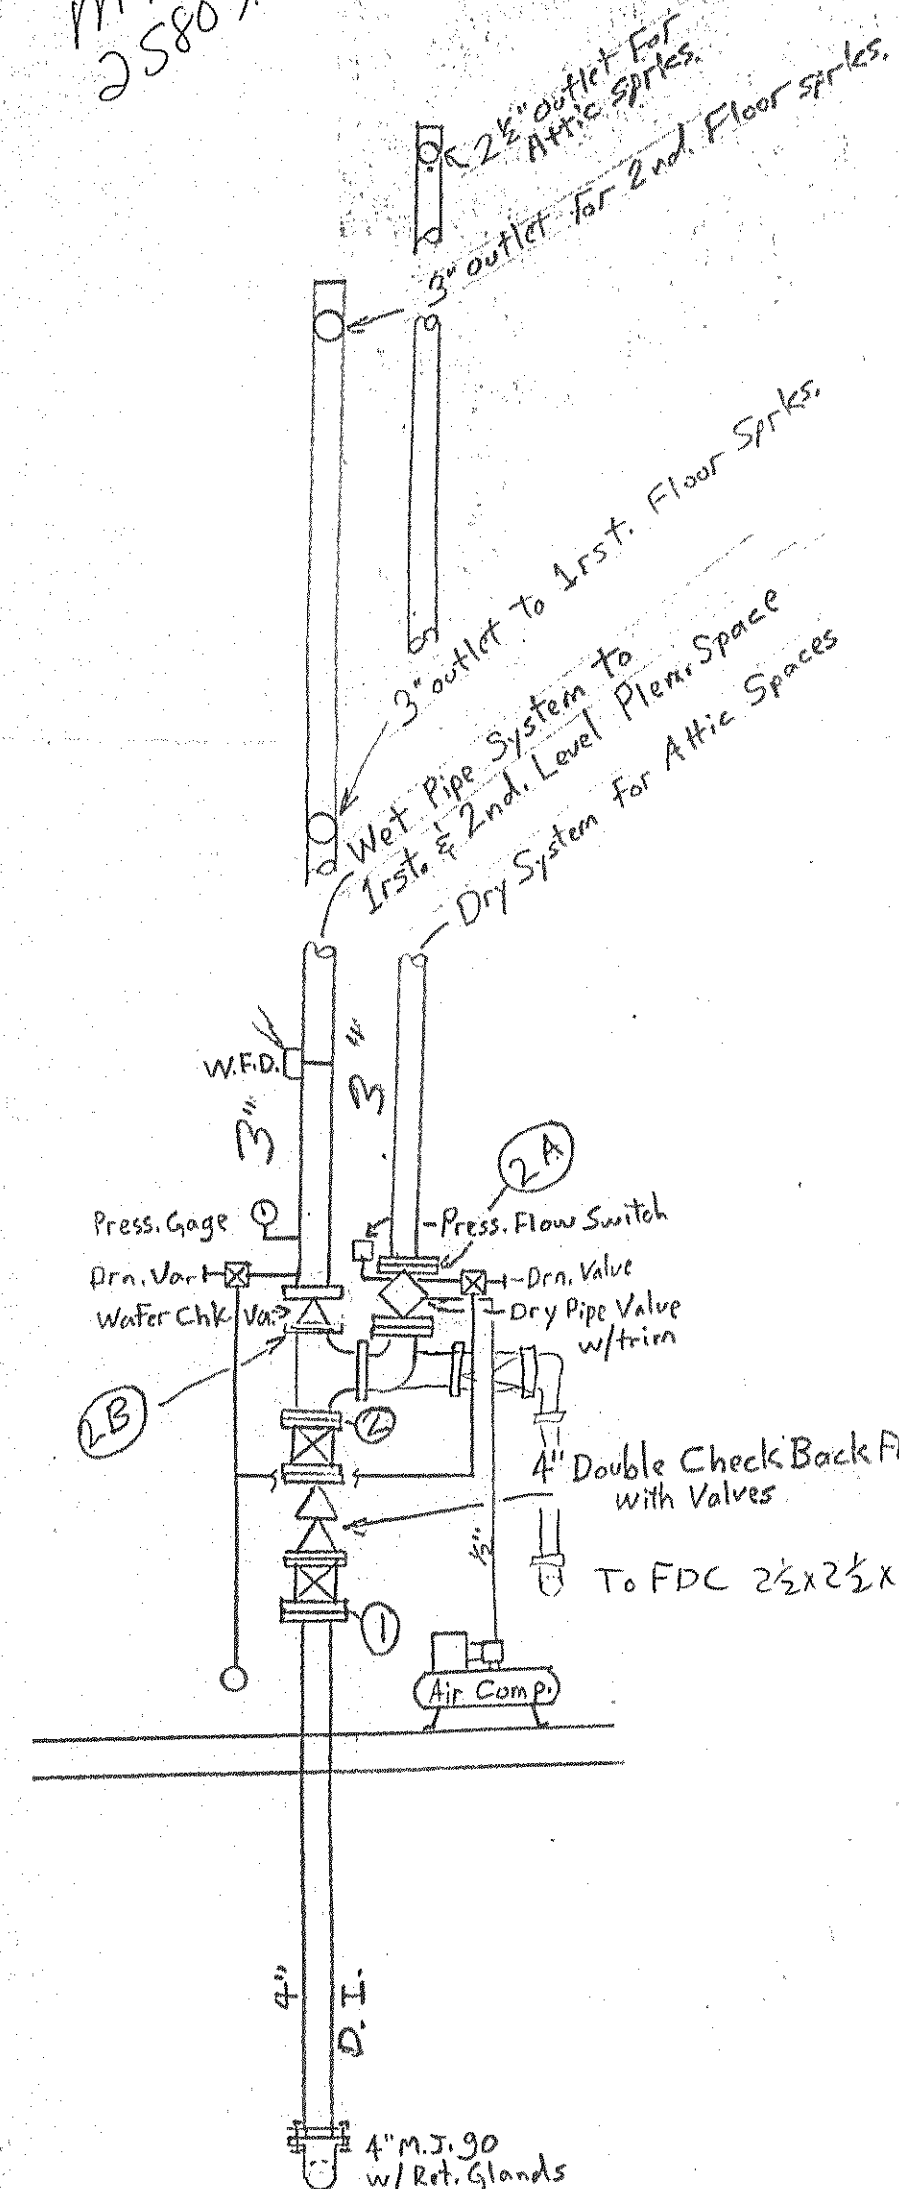


RISER DETAIL
N.T.S.

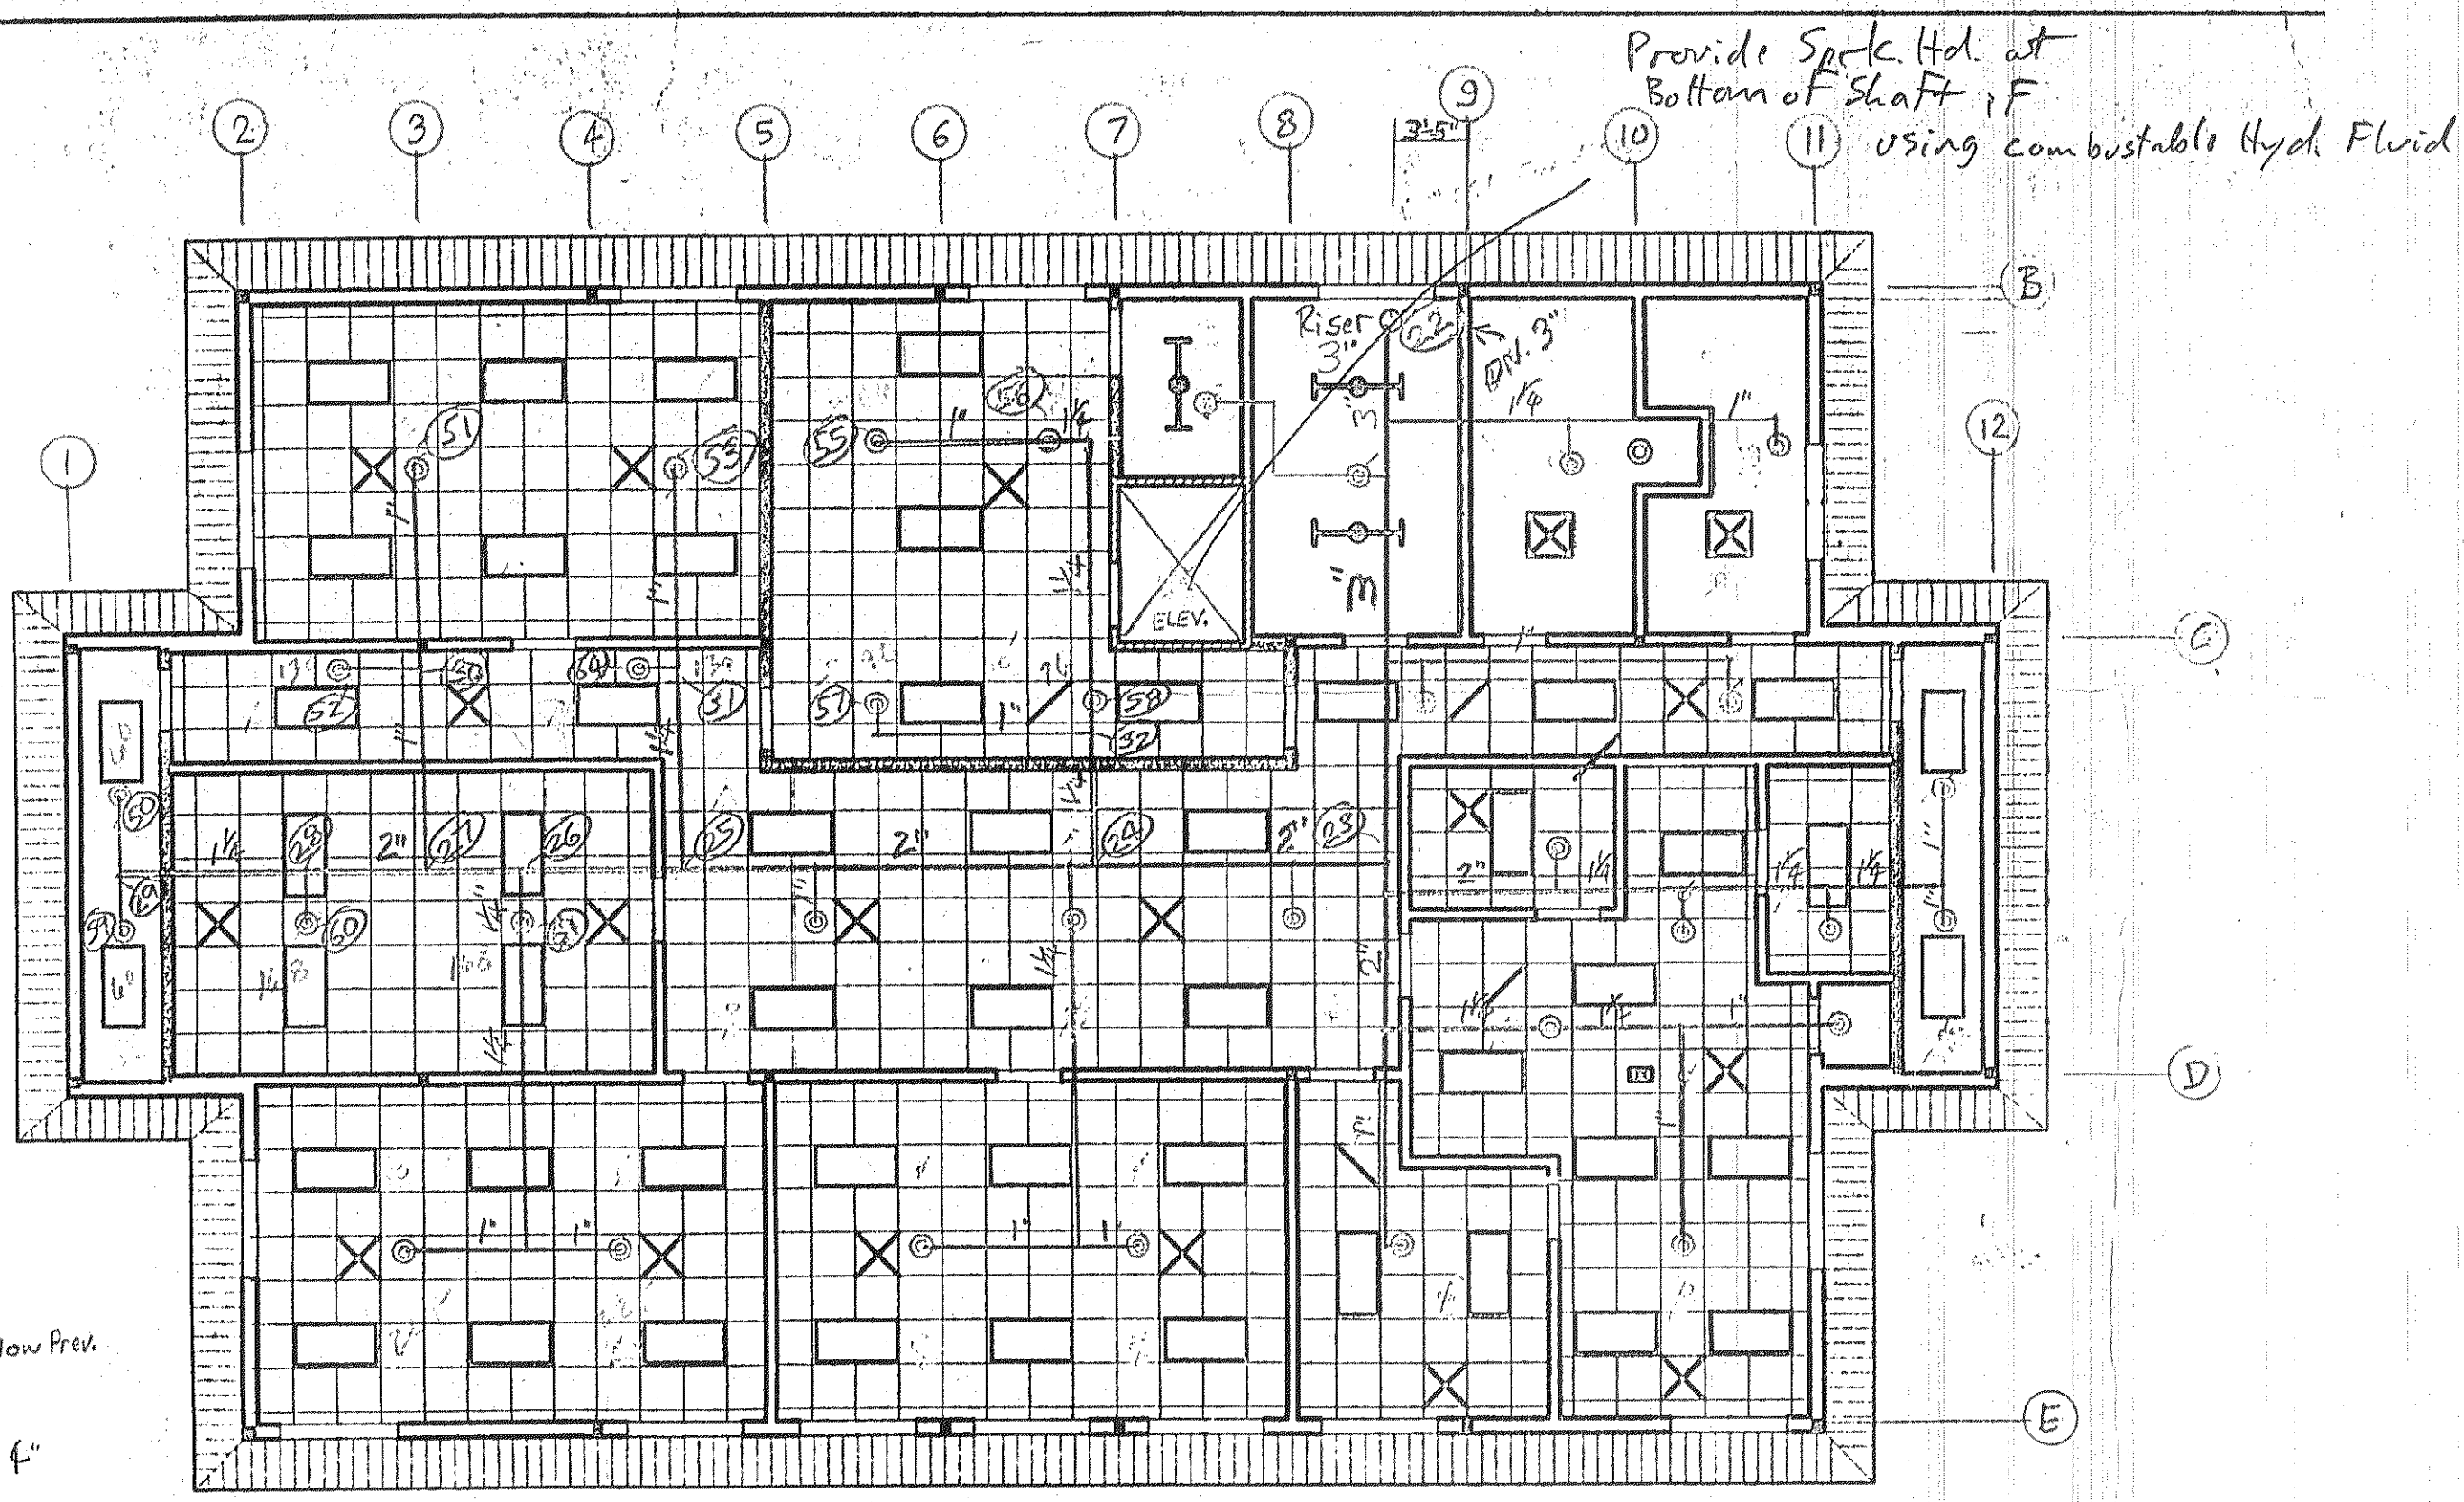


**SECOND FLOOR
REFLECTED CEILING PLAN**
SCALE: 1/8" = 1'-0"

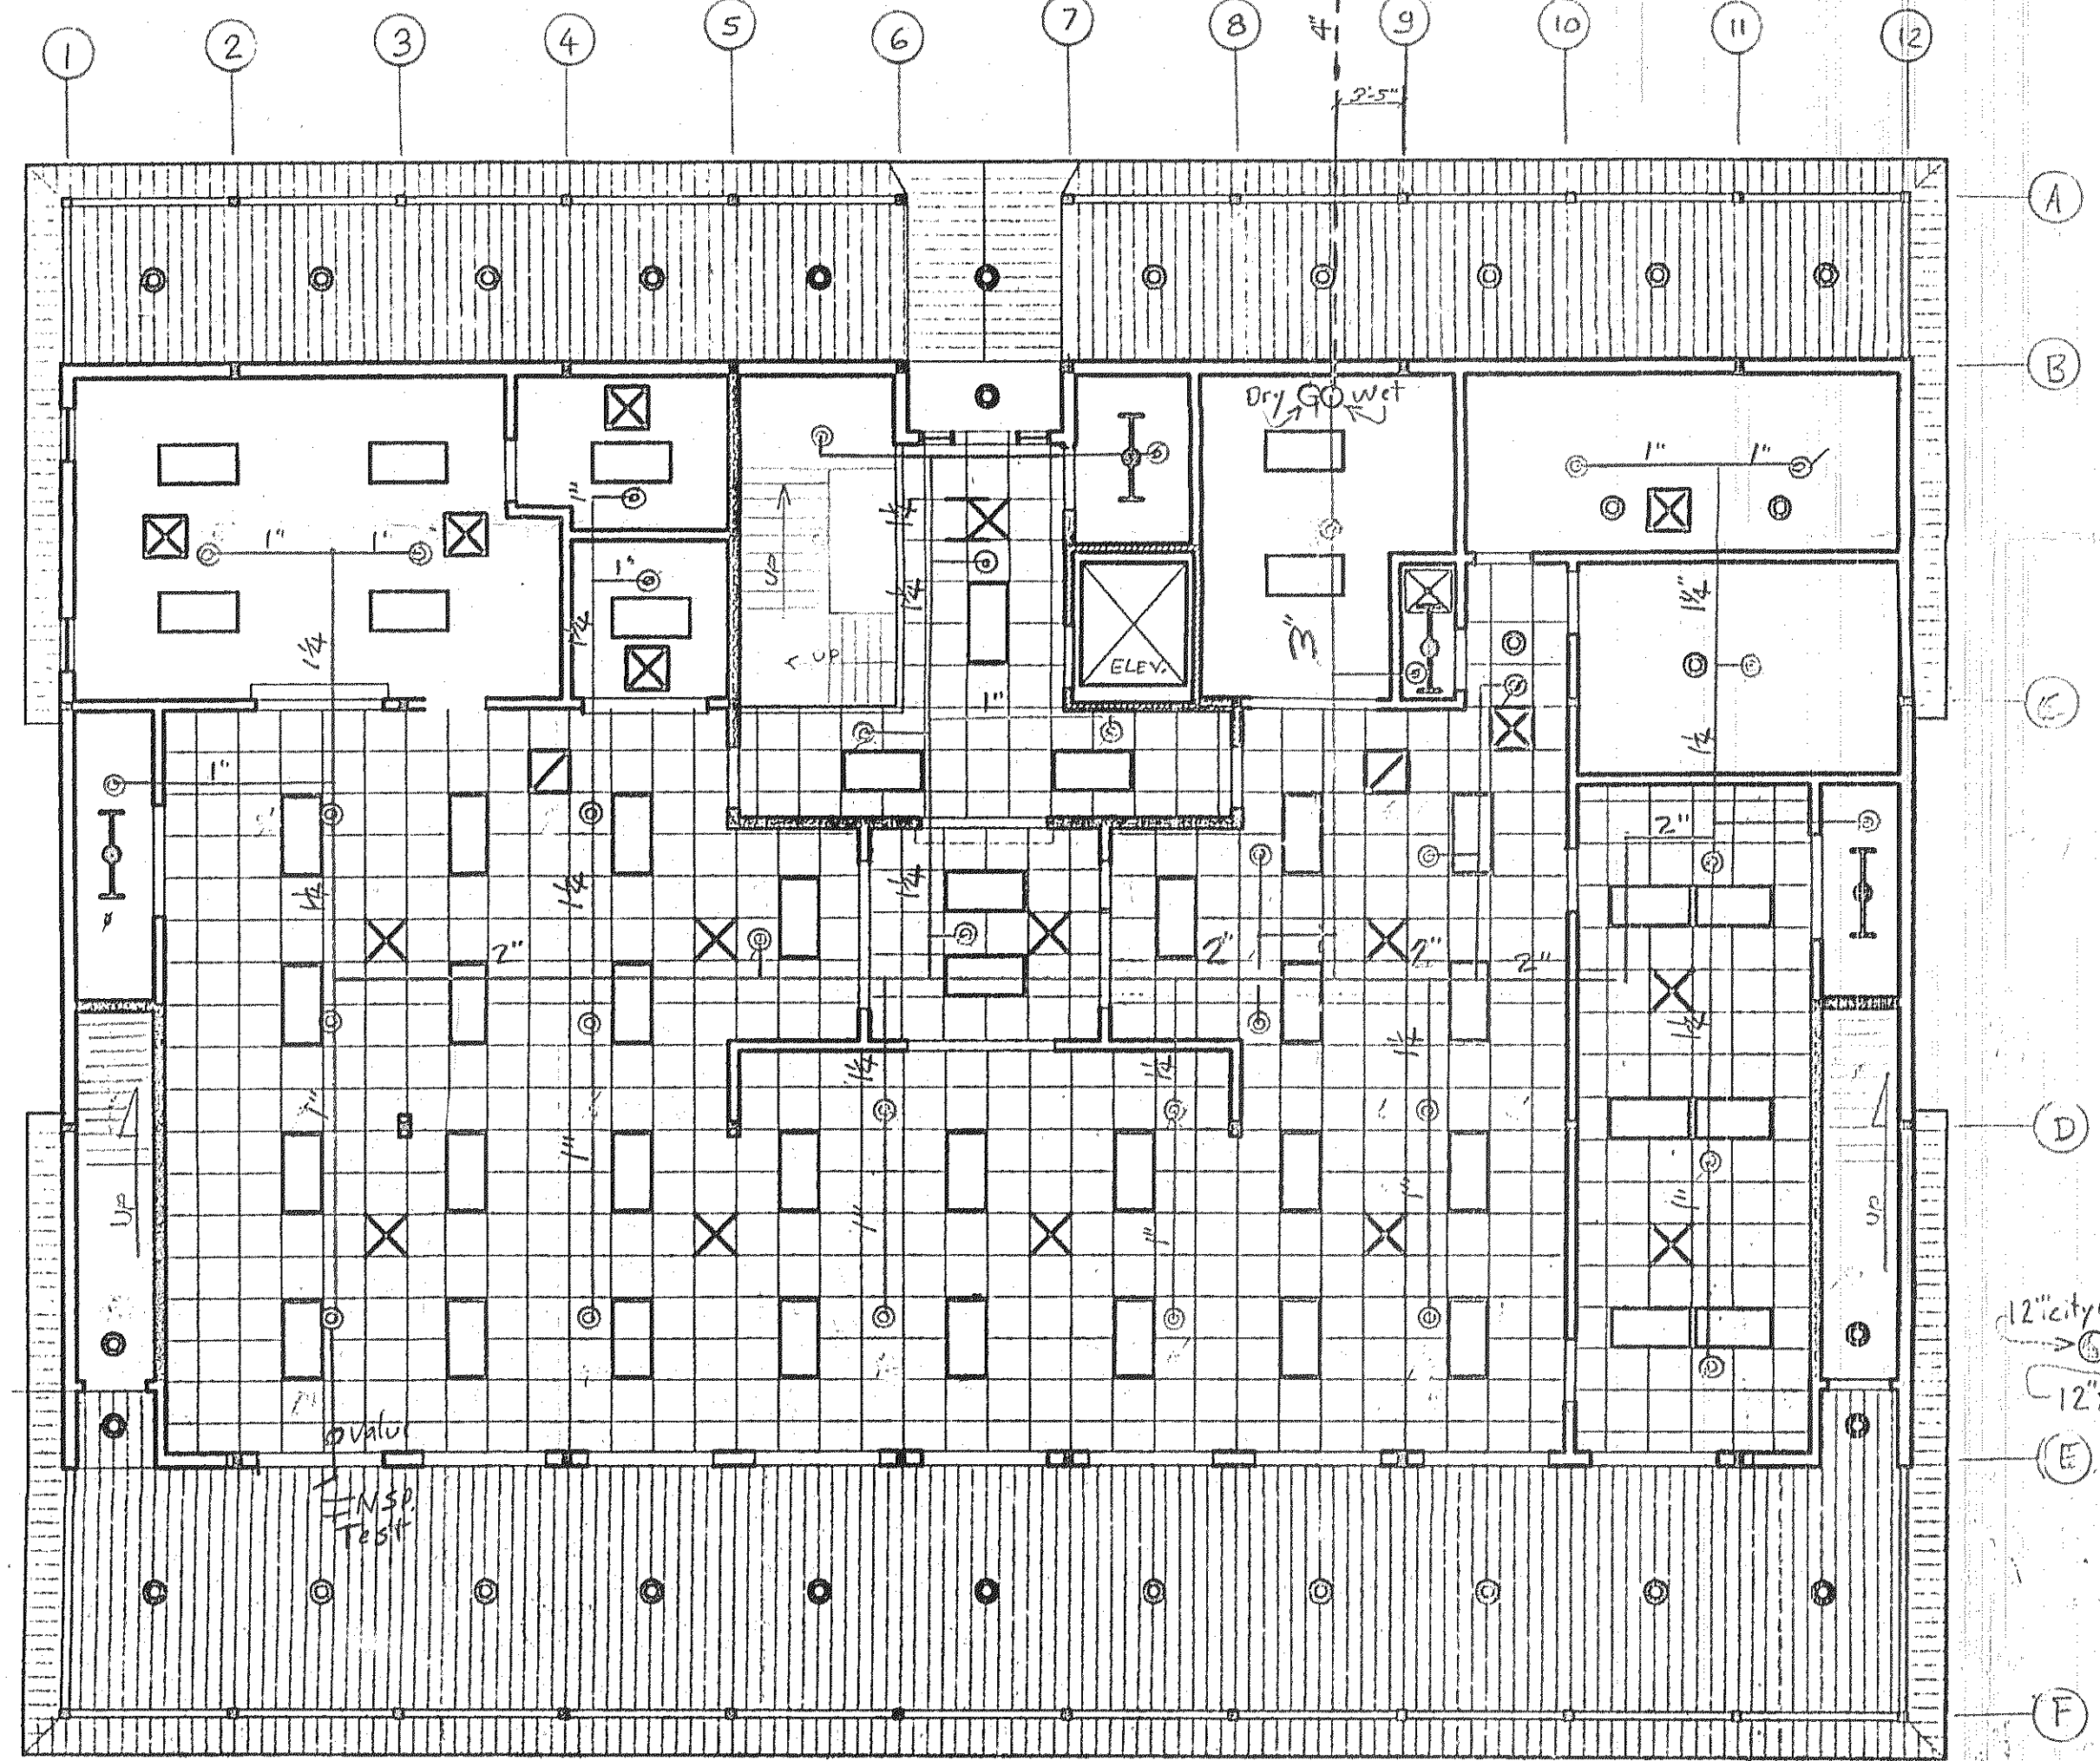

**FIRST FLOOR
REFLECTED CEILING PLAN**
SCALE: 1/8" = 1'-0"

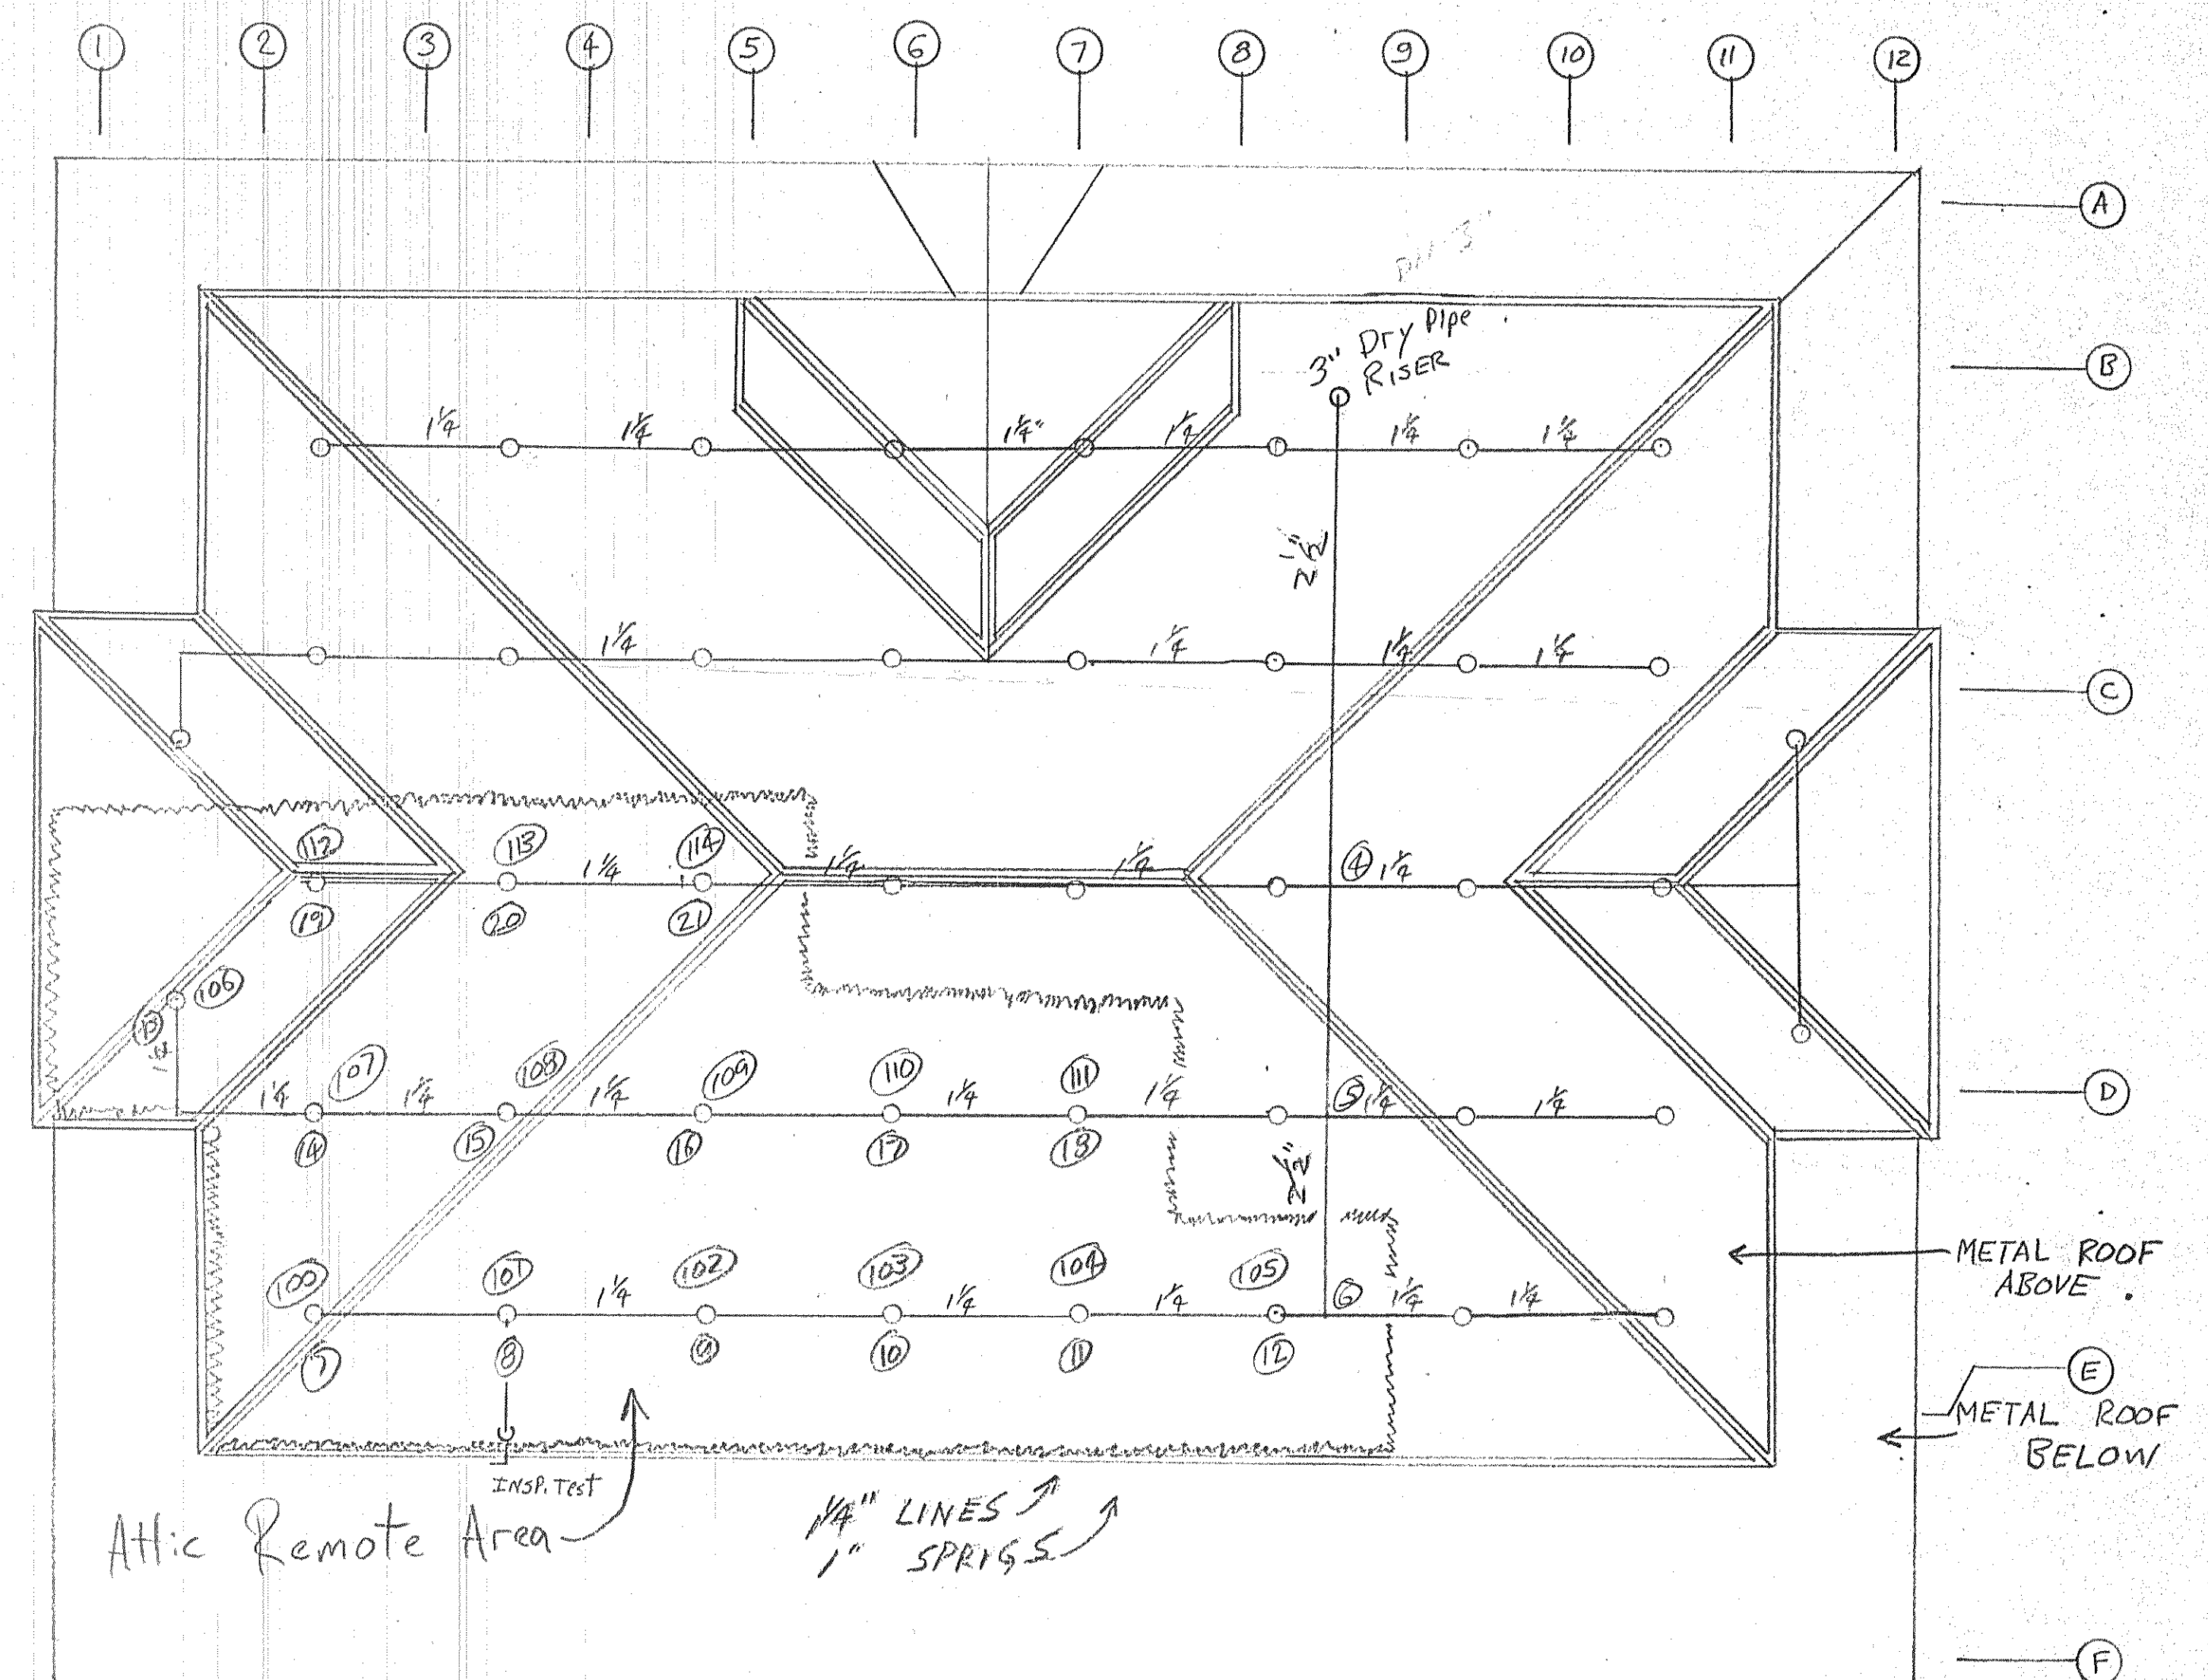

ROOF PLAN
Scale - 1/8" = 1'-0"

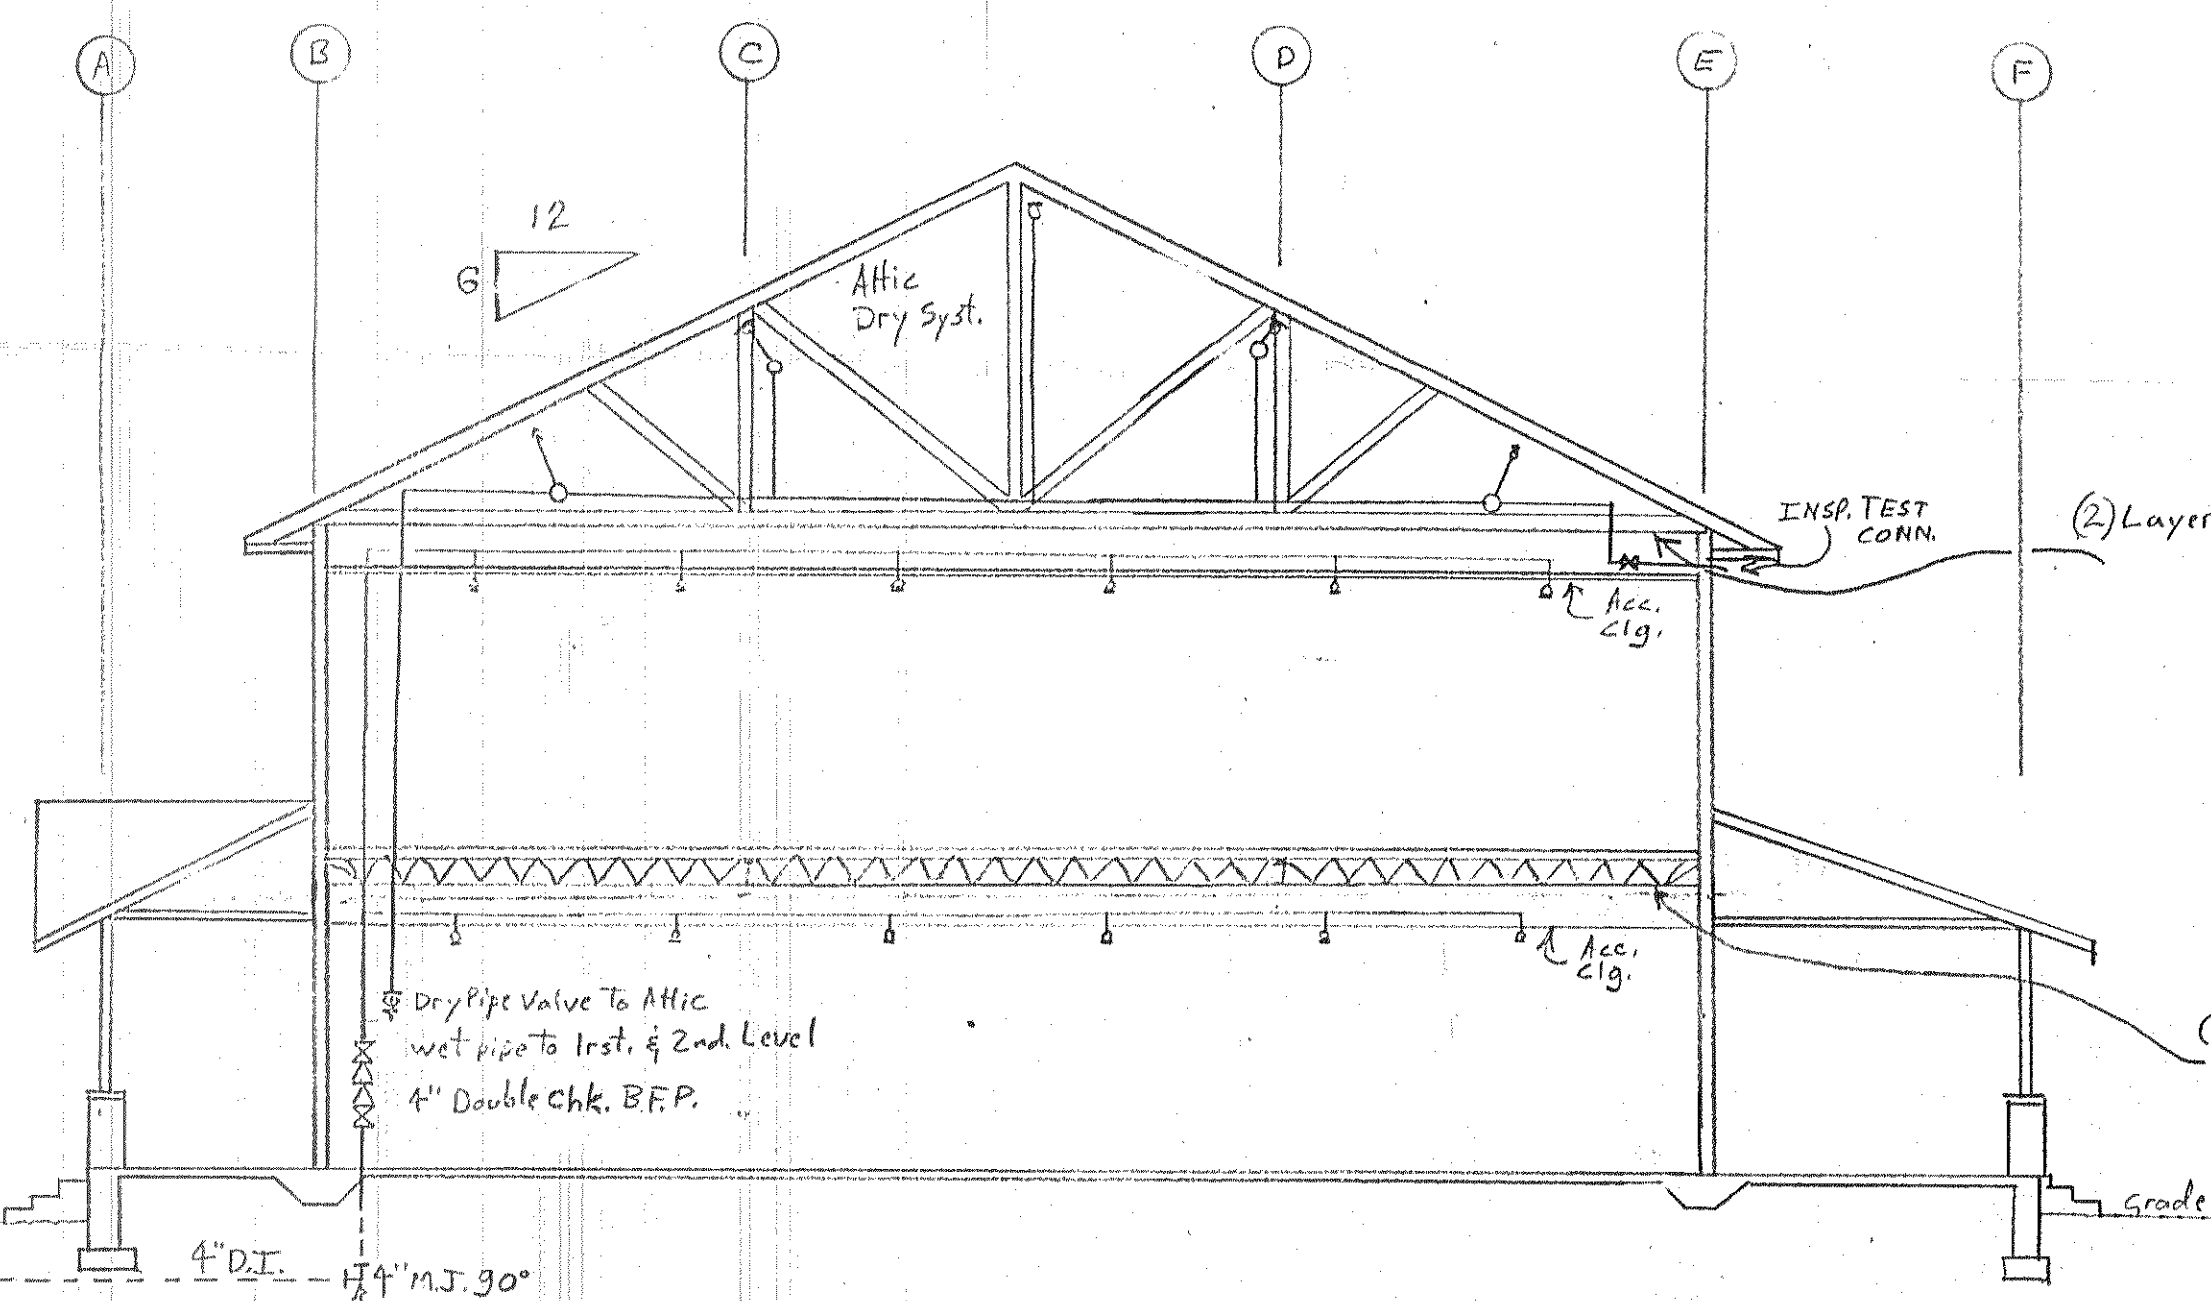

Notes:

1. Attic System is Dry Valve w/ Steel Pipe.
2. 1st. & 2nd. Level Sprks. are wet system with CPVC Pipe & Fittings 1"-2" only
3. System installed per Light Hazard, NFPA-13 requirements
4. Electric Flow Switches with Bell provided.
5. O - indicates Hydraulic node point - See Calc.

REVIEWED
DEC 5 1998
JACKSONVILLE FIRE
PREVENTION DIVISION
NO EXCEPTIONS
EXCEPTIONS AS NOTED
SHEET #

FIRE SPRINKLER SERV. of N.E. FL.
Address: P.O. Box 97861 Jax., FL 32236 - 904-388-2012
JOB: THE BRIDGE of N.E. FL.
8th. St. Jax., FL.

Date: 12-9-98 Scale: 1/8" = 1'-0" Draw: 1 of 1

12/16/98